


1-2017 CABLES REMOVE THE METAL DECK AND ADD STEEL CABLES IN IT'S PLACE AND CHANGE THE DETAILS TO MATCH ADDING THE CABLES.

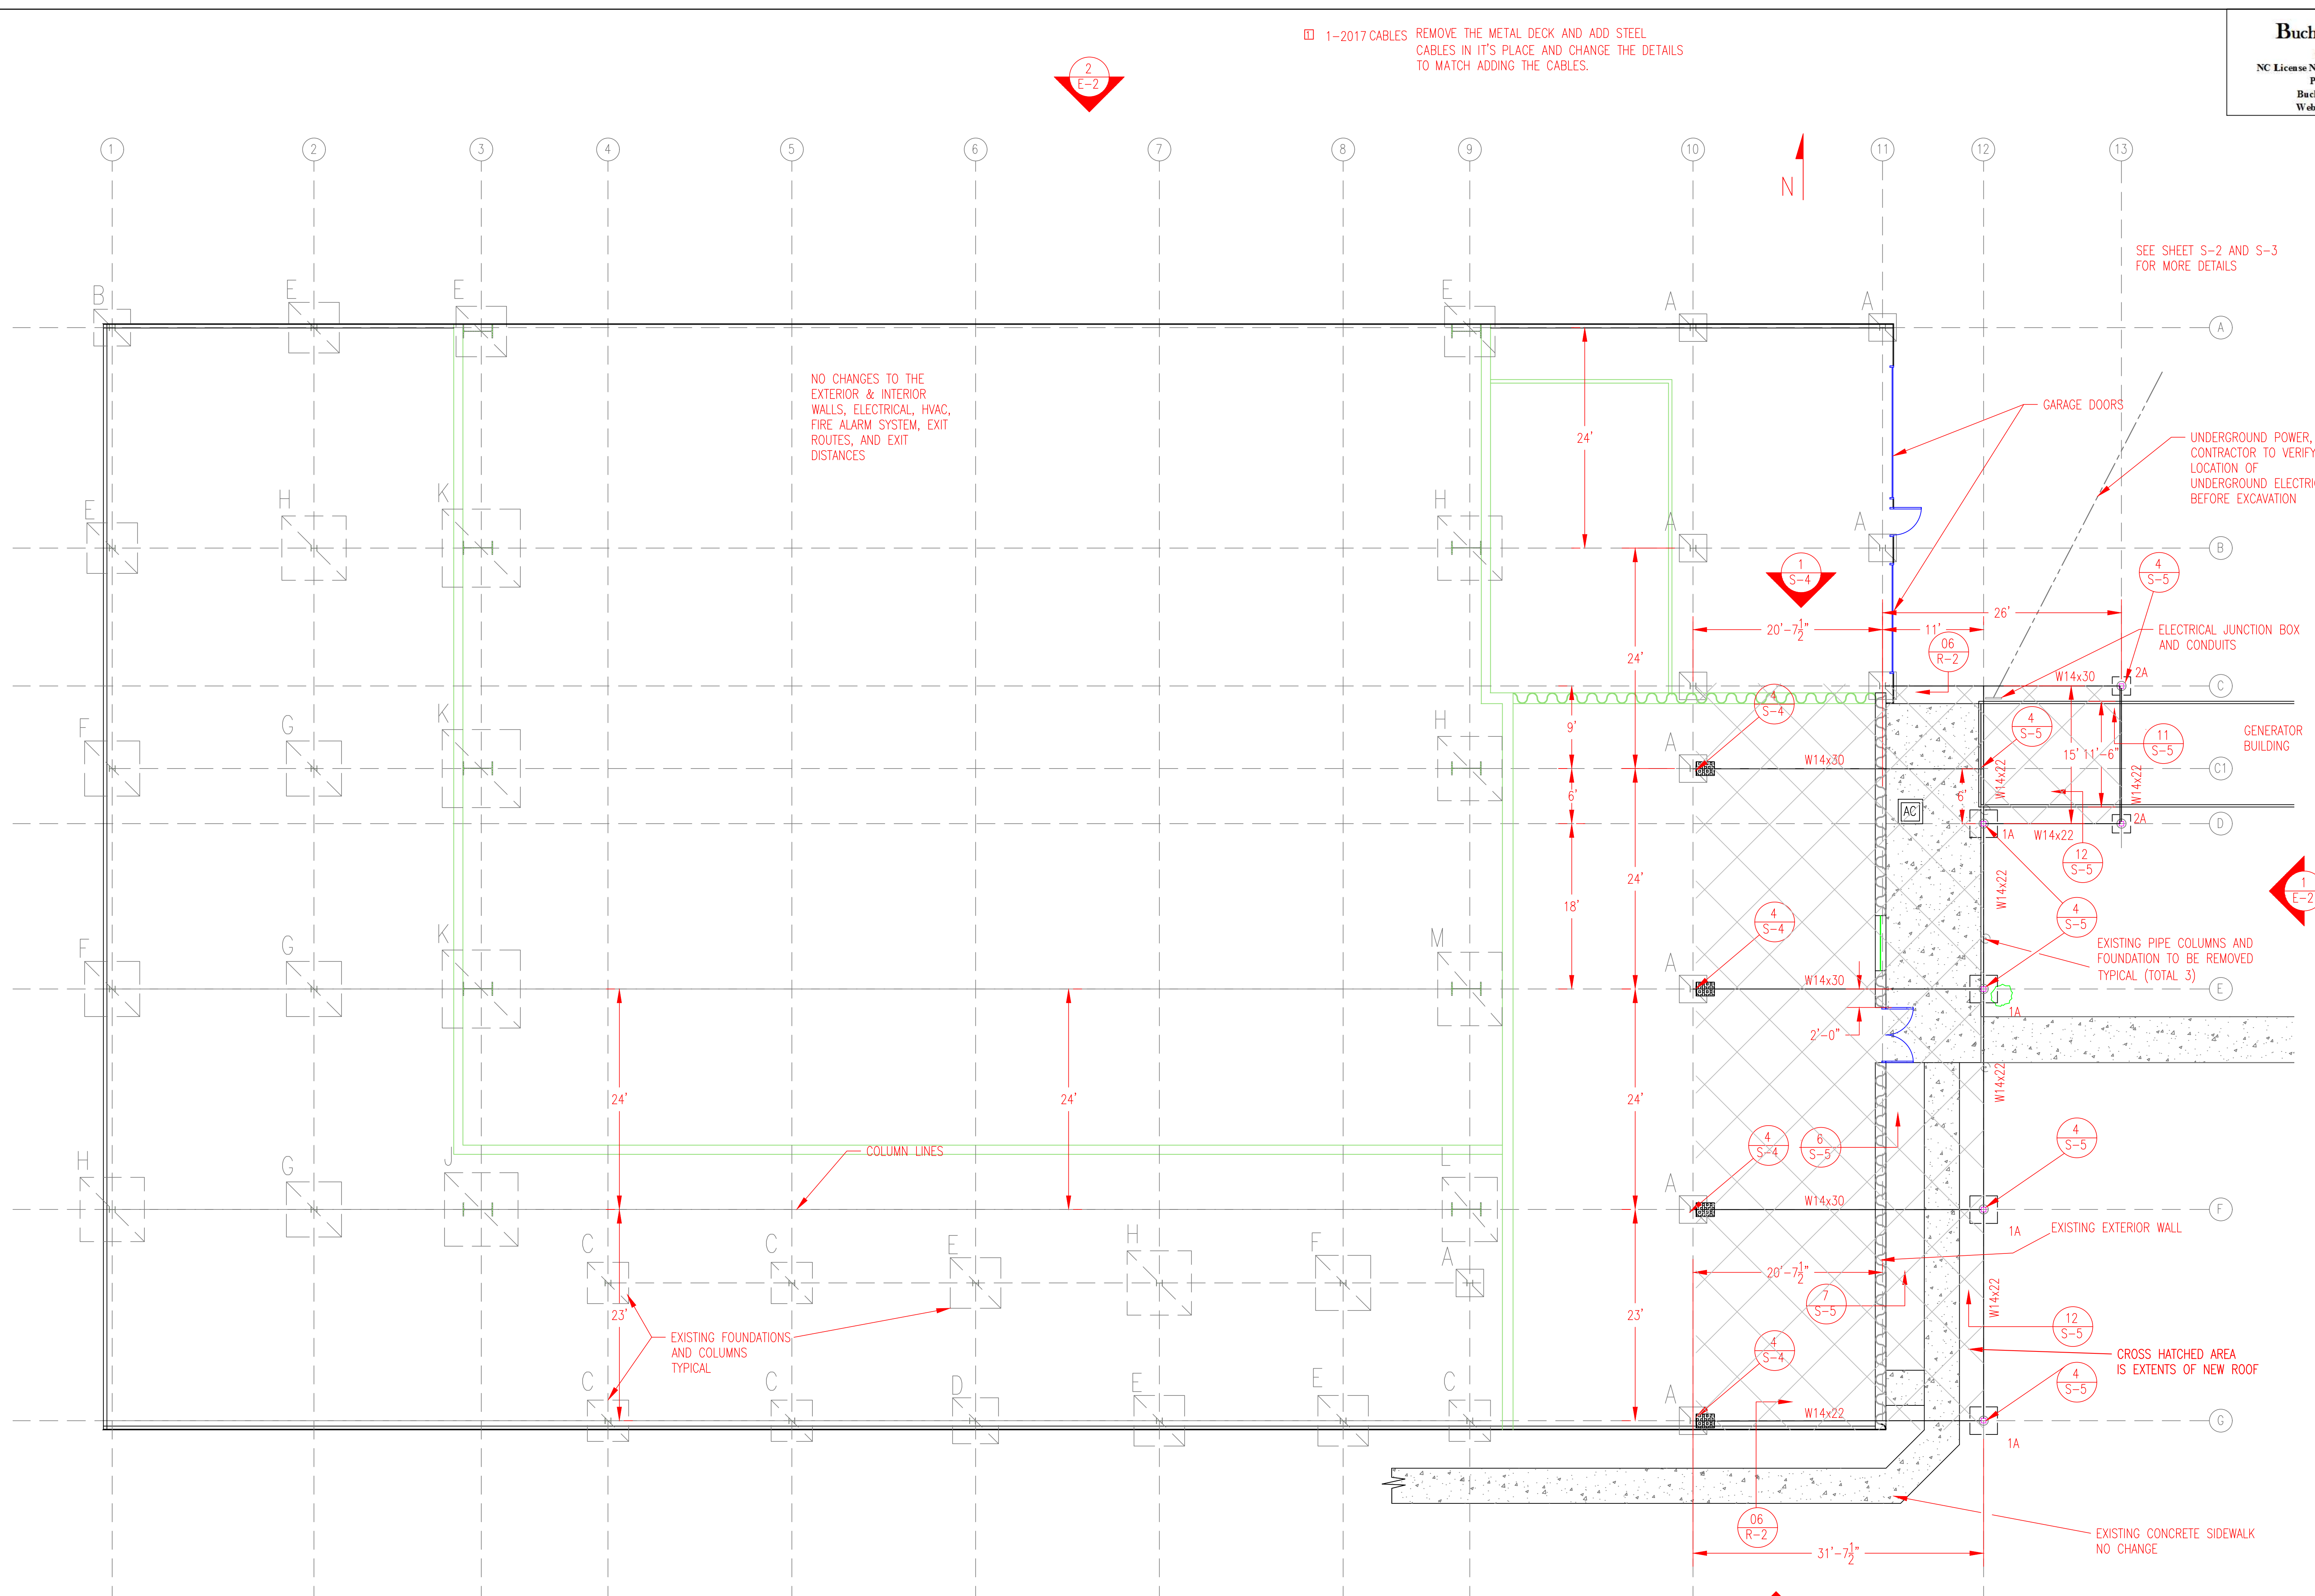

NO CHANGES TO THE EXTERIOR & INTERIOR WALLS, ELECTRICAL, HVAC, FIRE ALARM SYSTEM, EXIT ROUTES, AND EXIT DISTANCES

SEE SHEET S-2 AND S-3 FOR MORE DETAILS

UNDERGROUND POWER, CONTRACTOR TO VERIFY LOCATION OF UNDERGROUND ELECTRICAL BEFORE EXCAVATION

ELECTRICAL JUNCTION BOX AND CONDUITS

GENERATOR BUILDING

EXISTING PIPE COLUMNS AND FOUNDATION TO BE REMOVED TYPICAL (TOTAL 3)

EXISTING EXTERIOR WALL

CROSS HATCHED AREA IS EXTENTS OF NEW ROOF

EXISTING CONCRETE SIDEWALK NO CHANGE

1 S-1 OVERALL PLAN VIEW OF BUILDING  
 SCALE 1/8"=1'-0"

FOR CONSTRUCTION

Nelson Hall and Associates, Inc.  
 Roof Consulting Services  
 1001 Lancaster Ave.  
 Monroe, NC 28112



JAARS, INC.  
 PO BOX 248  
 WAXHAW, NC  
 OWNER

**JAARS ROOF OVERLAY and ROOF EXTENSION**  
 7620 Jaars Road, WAXHAW, NC

MARK	DATE	DESCRIPTION
1	1-2017	CABLES

PROJECT NO: ----  
 CAD DWG FILE: HANGER DRAWING.DWG  
 DRAWN BY: DOUGLAS BUCHANAN, PE  
 CHK'D BY: DOUGLAS BUCHANAN, PE  
 DATE: 11-4-2016  
 COPYRIGHT:  
 SHEET TITLE:

**OVERALL FOUNDATION**

S-1